



GENERAL NOTES

THIS DRAWING AND THE RESIDENT COVERS ARE CONFIDENTIAL AND THE PROPERTY OF D.F.K. ENGINEERING CANADA LTD. AND SHALL NOT BE REPRODUCED, COPIED, EITHER WHOLLY OR IN PART, OR USED FOR ANY PURPOSE WHATSOEVER WITHOUT THE WRITTEN CONSENT OF THE OWNER.

NOTE

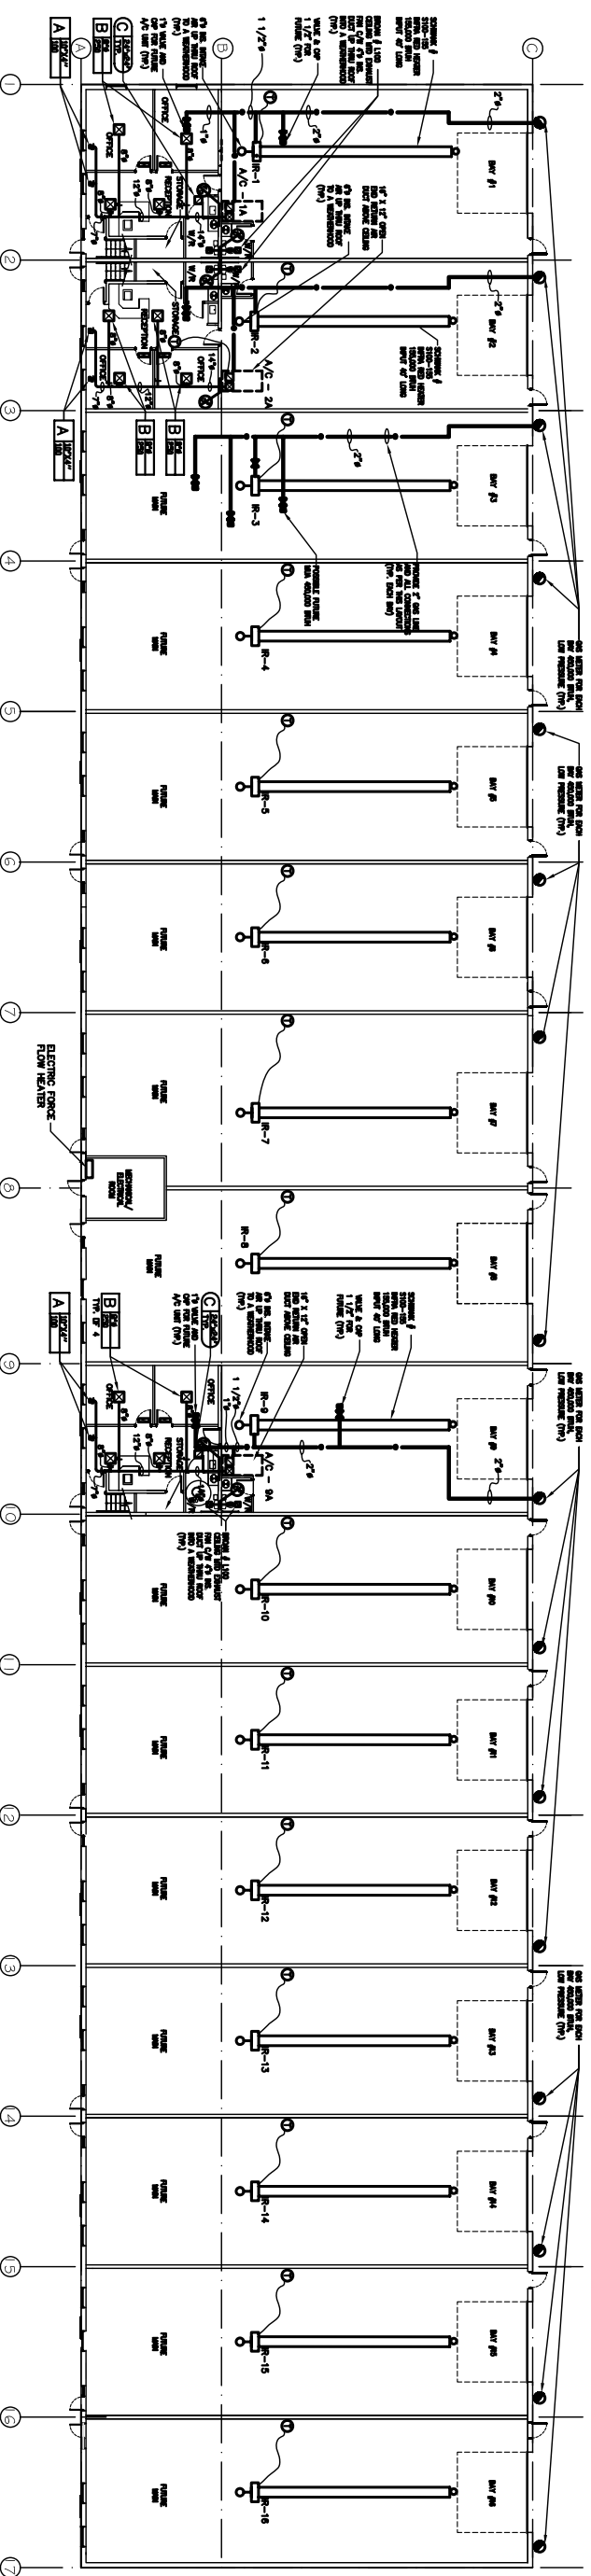

1 MAIN FLOOR-HVAC LAYOUT
SCALE: 1/16"=1'-0"

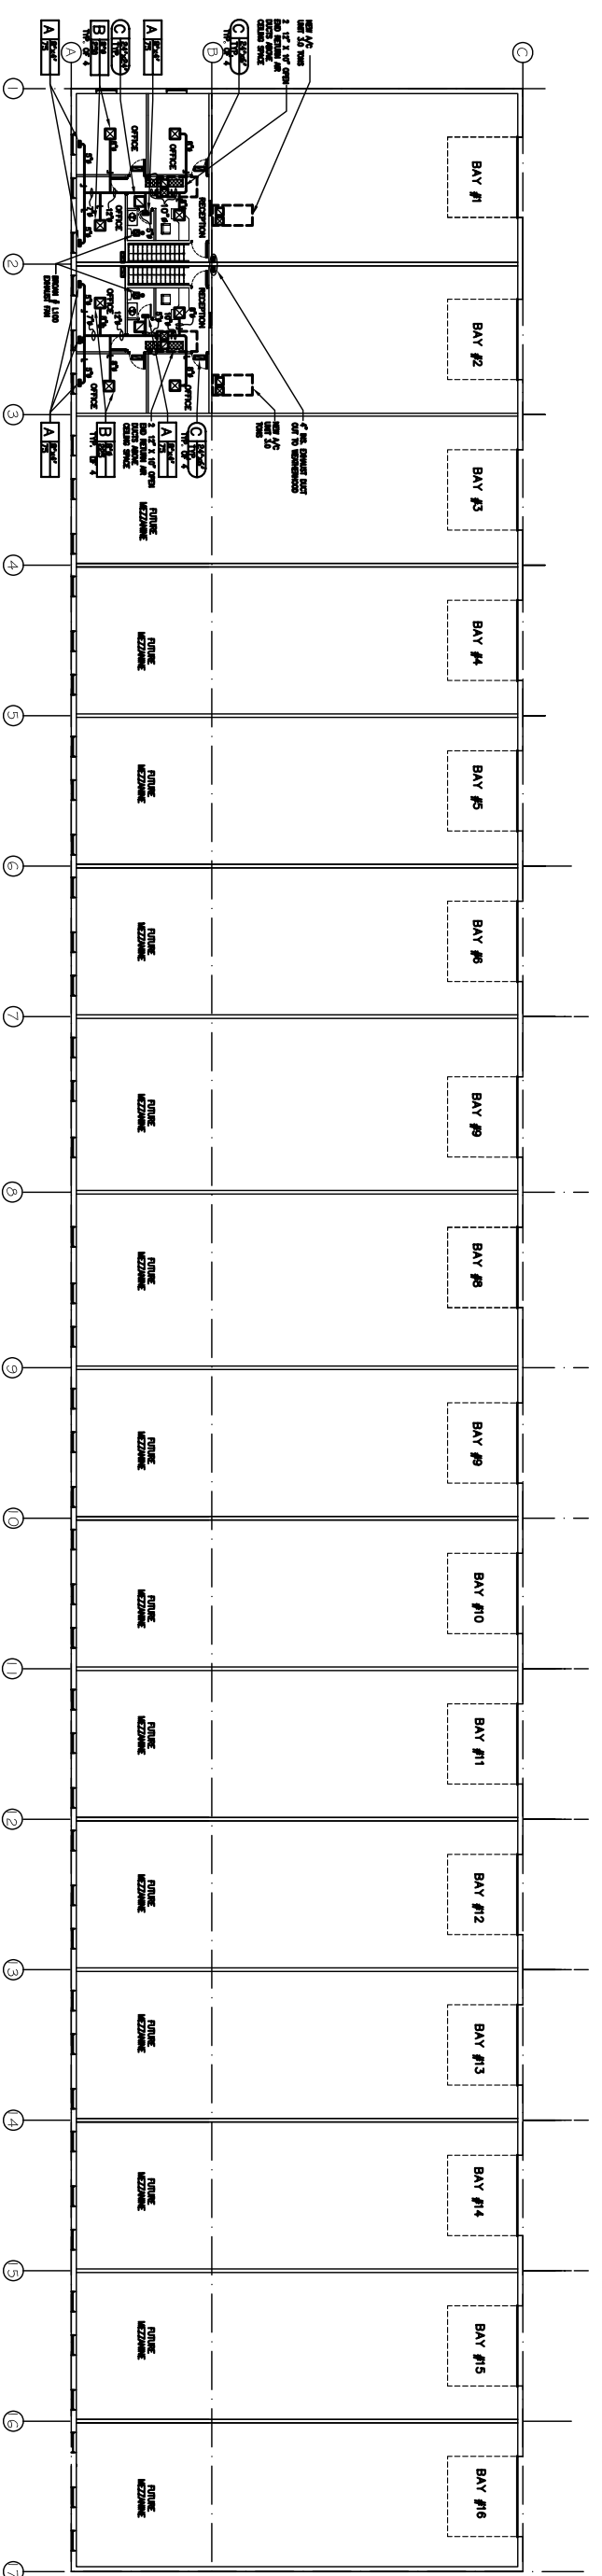

2 MEZZANINE LEVEL-HVAC LAYOUT
SCALE: 1/16"=1'-0"

NOTE:

- A/C UNITS TO BE LENNOX #TGA 048S2B
- 120,000 BTUH INPUT HEATING, 120,000 BTUH OUTPUT HEATING, 36,000 BTUH COOLING COIL.
- 1200 CFM @ 0.5" ESP
- 208/3/60, 17 AMP, 25 FUSE AMPS, 850 LBS WEIGHT c/w
- AUTO CHANGE OVER THERMOSTAT ROOF CURB, ECONOMIZER AND BELT DRIVE.

NO.	DATE	DESCRIPTION



SEALS

PENNY TO PRACTICE
D.F.K. ENGINEERING CANADA LTD.
Signature
Derek Robert Munnis P. Eng.
The Association of Professional Engineers, Technicians and Geoscientists of Alberta



D.F.K. ENGINEERING
CANADA LTD.
CONSULTING ENGINEERS
PH: 403.236.1095 FAX: 403.279.2698
EM: dfk@dfk.ca
2120 B. S. 8800 VENTURE AVE S.E.
CALGARY, ALBERTA, T3S 0A2

PROJECT TITLE:
OFFICE WAREHOUSE CONDOMINIUM
240040 FRONTIER PLACE S/E
ROCKY VIEW ALBERTA

SHEET TITLE:
MAIN FLOOR PLAN & MEZZANINE LEVEL HVAC LAYOUT

DRAWN	CHECKED	APPROVED
R. KINAR	D. BURTON	G. PARRIS
SCALE: 1/16" = 1'-0"	PROJECT NO.: 29-2411	DATE: JULY 1, 2009
DATE: JULY 1, 2009	DATE PRINTED: AUG 20, 2009	REVISION:
M-4	OF 7	