

GENERAL NOTES

THE DRAWING AND THE DESIGN IT CONTAINS ARE THE PROPERTY OF D.F.K. ENGINEERING CANADA LIMITED. ANY SHALL NOT BE REPRODUCED OR TRANSMITTED IN ANY FORM OR BY ANY MEANS, ELECTRONIC OR MECHANICAL, INCLUDING PHOTOCOPYING, RECORDING, OR BY ANY INFORMATION STORAGE AND RETRIEVAL SYSTEM, WITHOUT THE WRITTEN CONSENT OF THE OWNER.

NOTE:



NO.	DATE	DESCRIPTION

SEALS:




PERMIT TO PRACTISE
D.F.K. ENGINEERING CANADA LTD.
 Signature: _____
 Date: **20th August, 2009**
 The Association of Professional Engineers, Geologists and Geophysicists of Alberta


D.F.K. ENGINEERING
 CANADA LTD.
 CONSULTING ENGINEERS
 PH: 403.236.1095 FAX: 403.279.2698
 EMail: dfkeng@outlook.com
 2120 B. - 8800 VENTURE AVE S.E.
 CALGARY, ALBERTA, T2S 0A2

PROJECT TITLE:
OFFICE WAREHOUSE
CONDOMINIUM
 240040 FRONTIER PLACE S.E
 ROCKY VIEW ALBERTA.
 SHEET TITLE:
ENLARGED PLANS
MAIN & MEZZANINE
HVAC LAYOUT

DRAWN	CHECKED	APPROVED
R. KUMAR	D. BERTON	G. PEARIS
SCALE: 1/8" = 1'-0"	PROJECT NO: 29-2411	
DATE: JULY 1, 2009	DATE PRINTED: AUG 20, 2009	REVISIONS:
M-6		
OF 7		

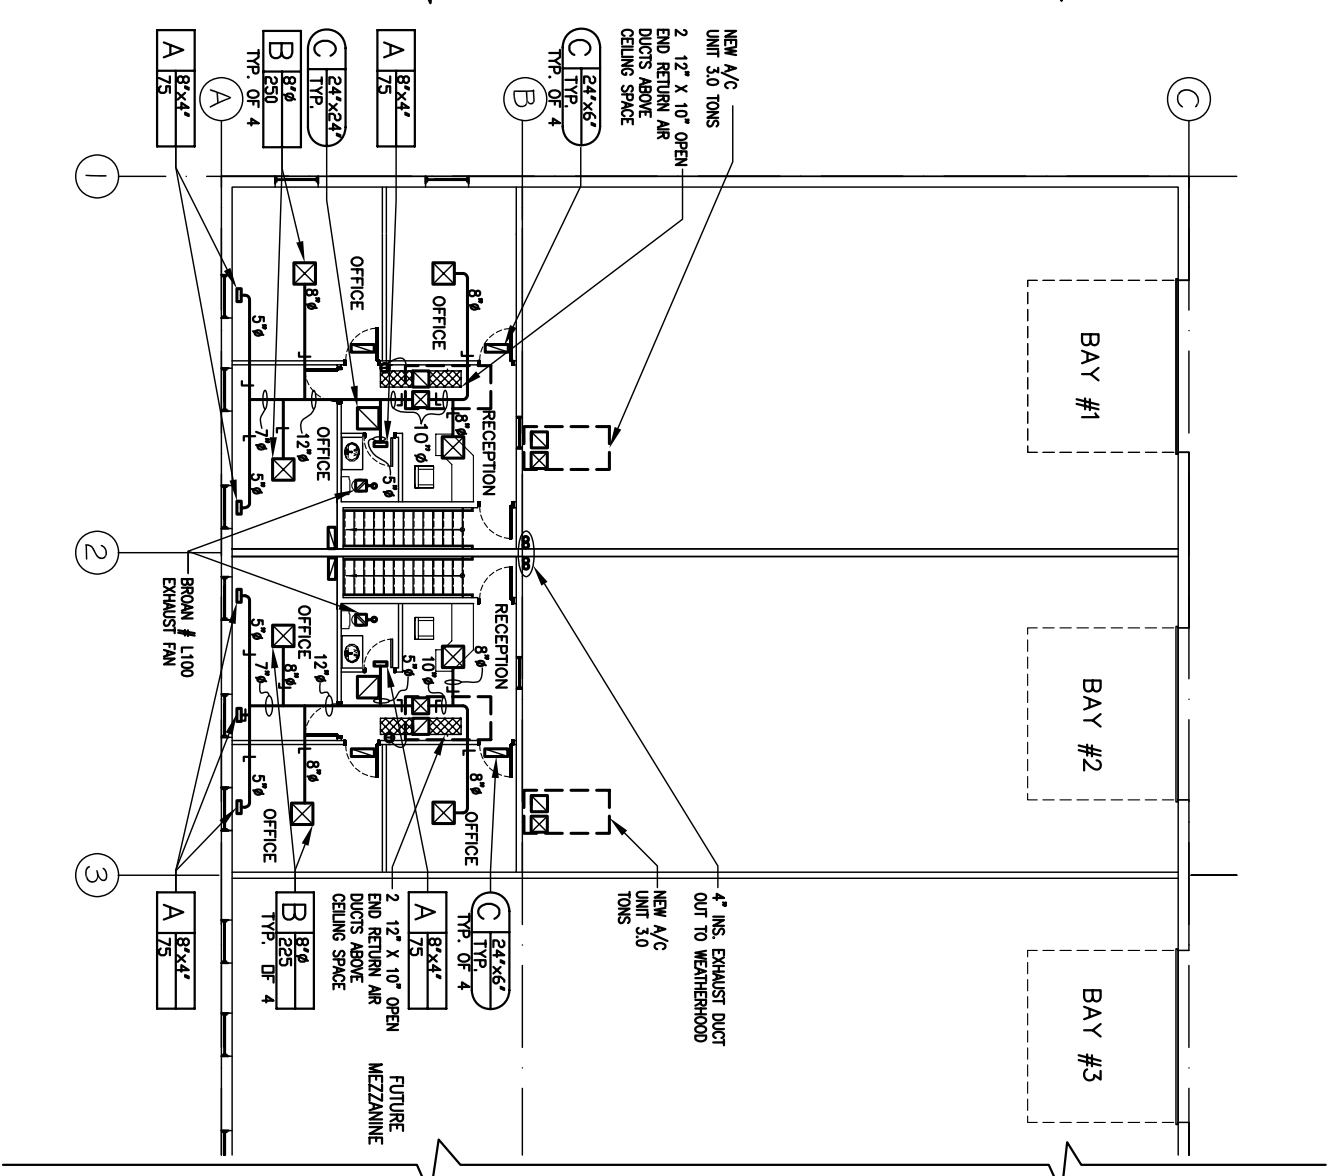

2 MEZZANINE LEVEL-HVAC LAYOUT
 M-6 SCALE: 1/8"=1'-0"

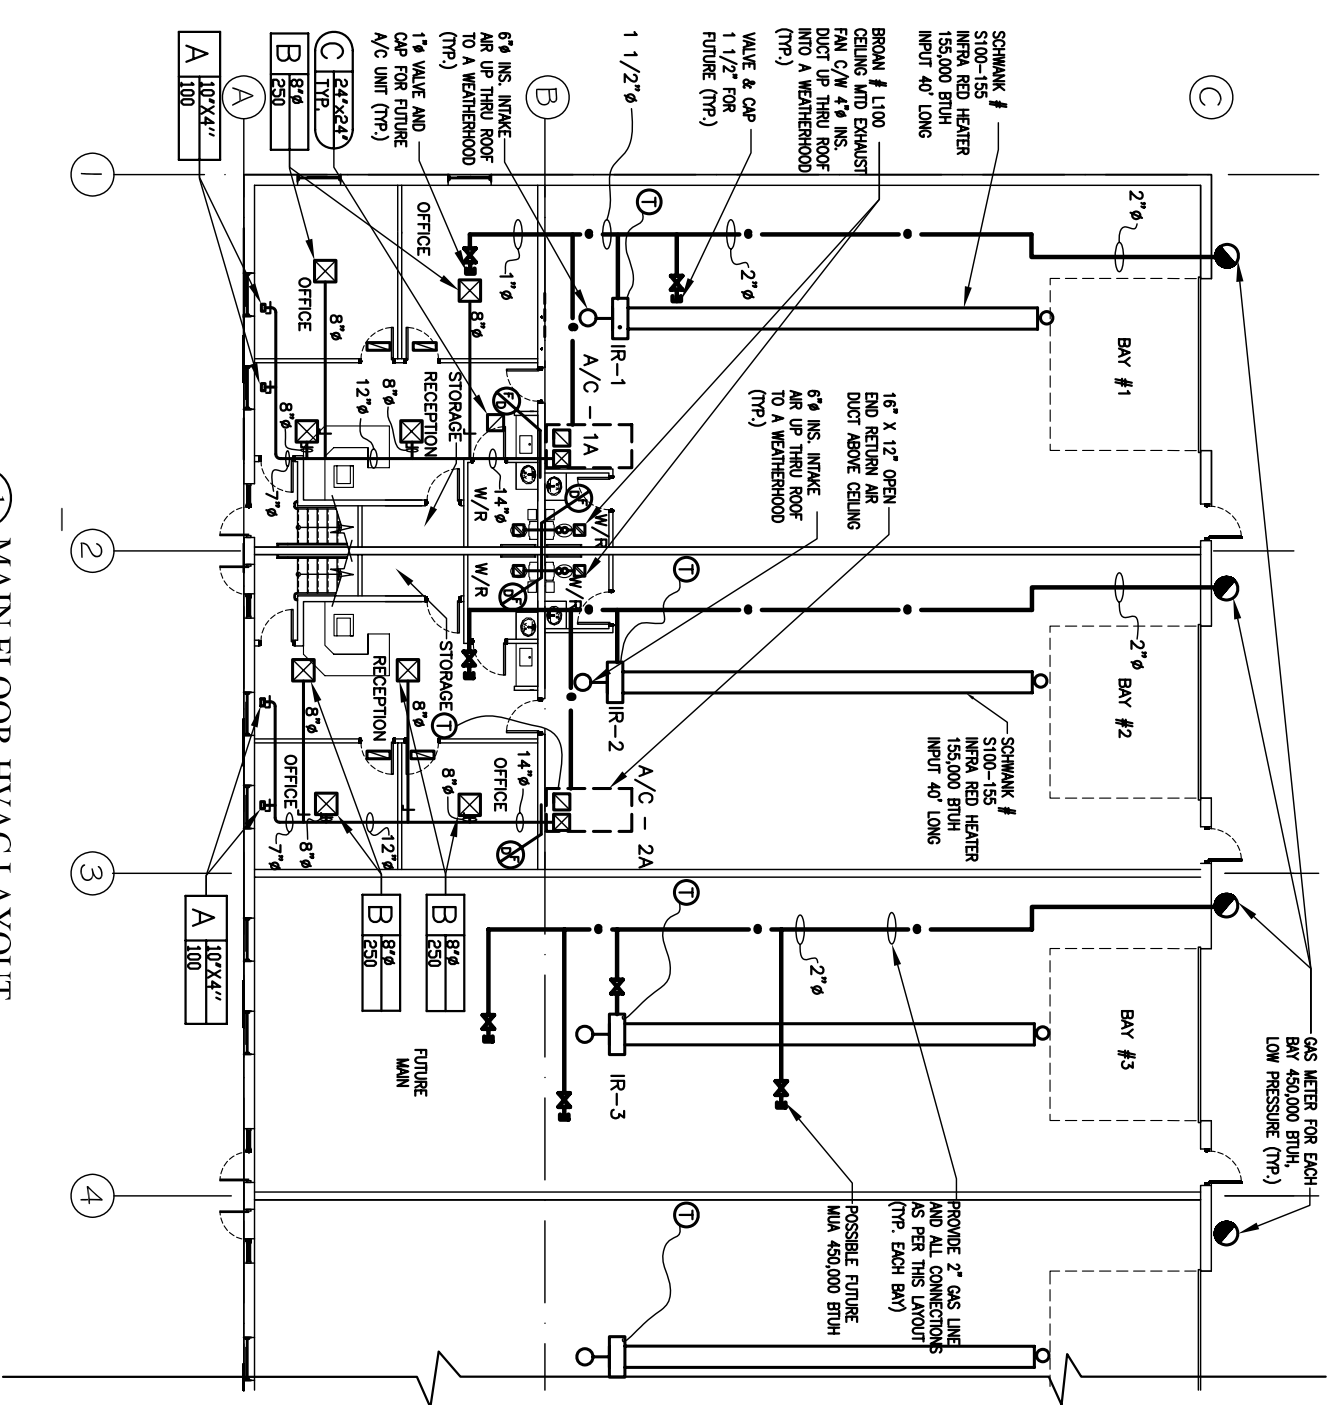

1 MAIN FLOOR-HVAC LAYOUT
 M-6 SCALE: 1/8"=1'-0"